


*Thomas R. Cook*



- PLAN NOTES:**
1. SEE DETAIL ON SHEET E3.0 FOR LIGHT INSTALLATION IN WATER FEATURE.
  2. CONNECT TO EXHAUST FANS IN MENS AND WOMENS RESTROOMS.
  3. CONNECT TO LIGHT FIXTURES.
  4. CONNECT TO SWITCHES.
  5. COORDINATE EXACT LOCATION OF LIGHT FIXTURES WITH DUCTWORK, PIPING, MECH. EQUIPMENT, ETC. AS REQUIRED.
  6. REFER TO ARCHITECTURAL REFLECTED CEILING PLAN FOR ACTUAL LOCATIONS OF LIGHT FIXTURES.
  7. LIGHT FIXTURE MOUNTED INSIDE DISPLAY CASE.
  8. LIGHT SWITCH TO BE LOCATED ON WALL BELOW LIGHT FIXTURE. COORDINATE EXACT LOCATION WITH ARCHITECT IN FIELD.
  9. FIXTURE TO BE MOUNTED AT 10'-0" AFF TO BOTTOM OF BOWL.

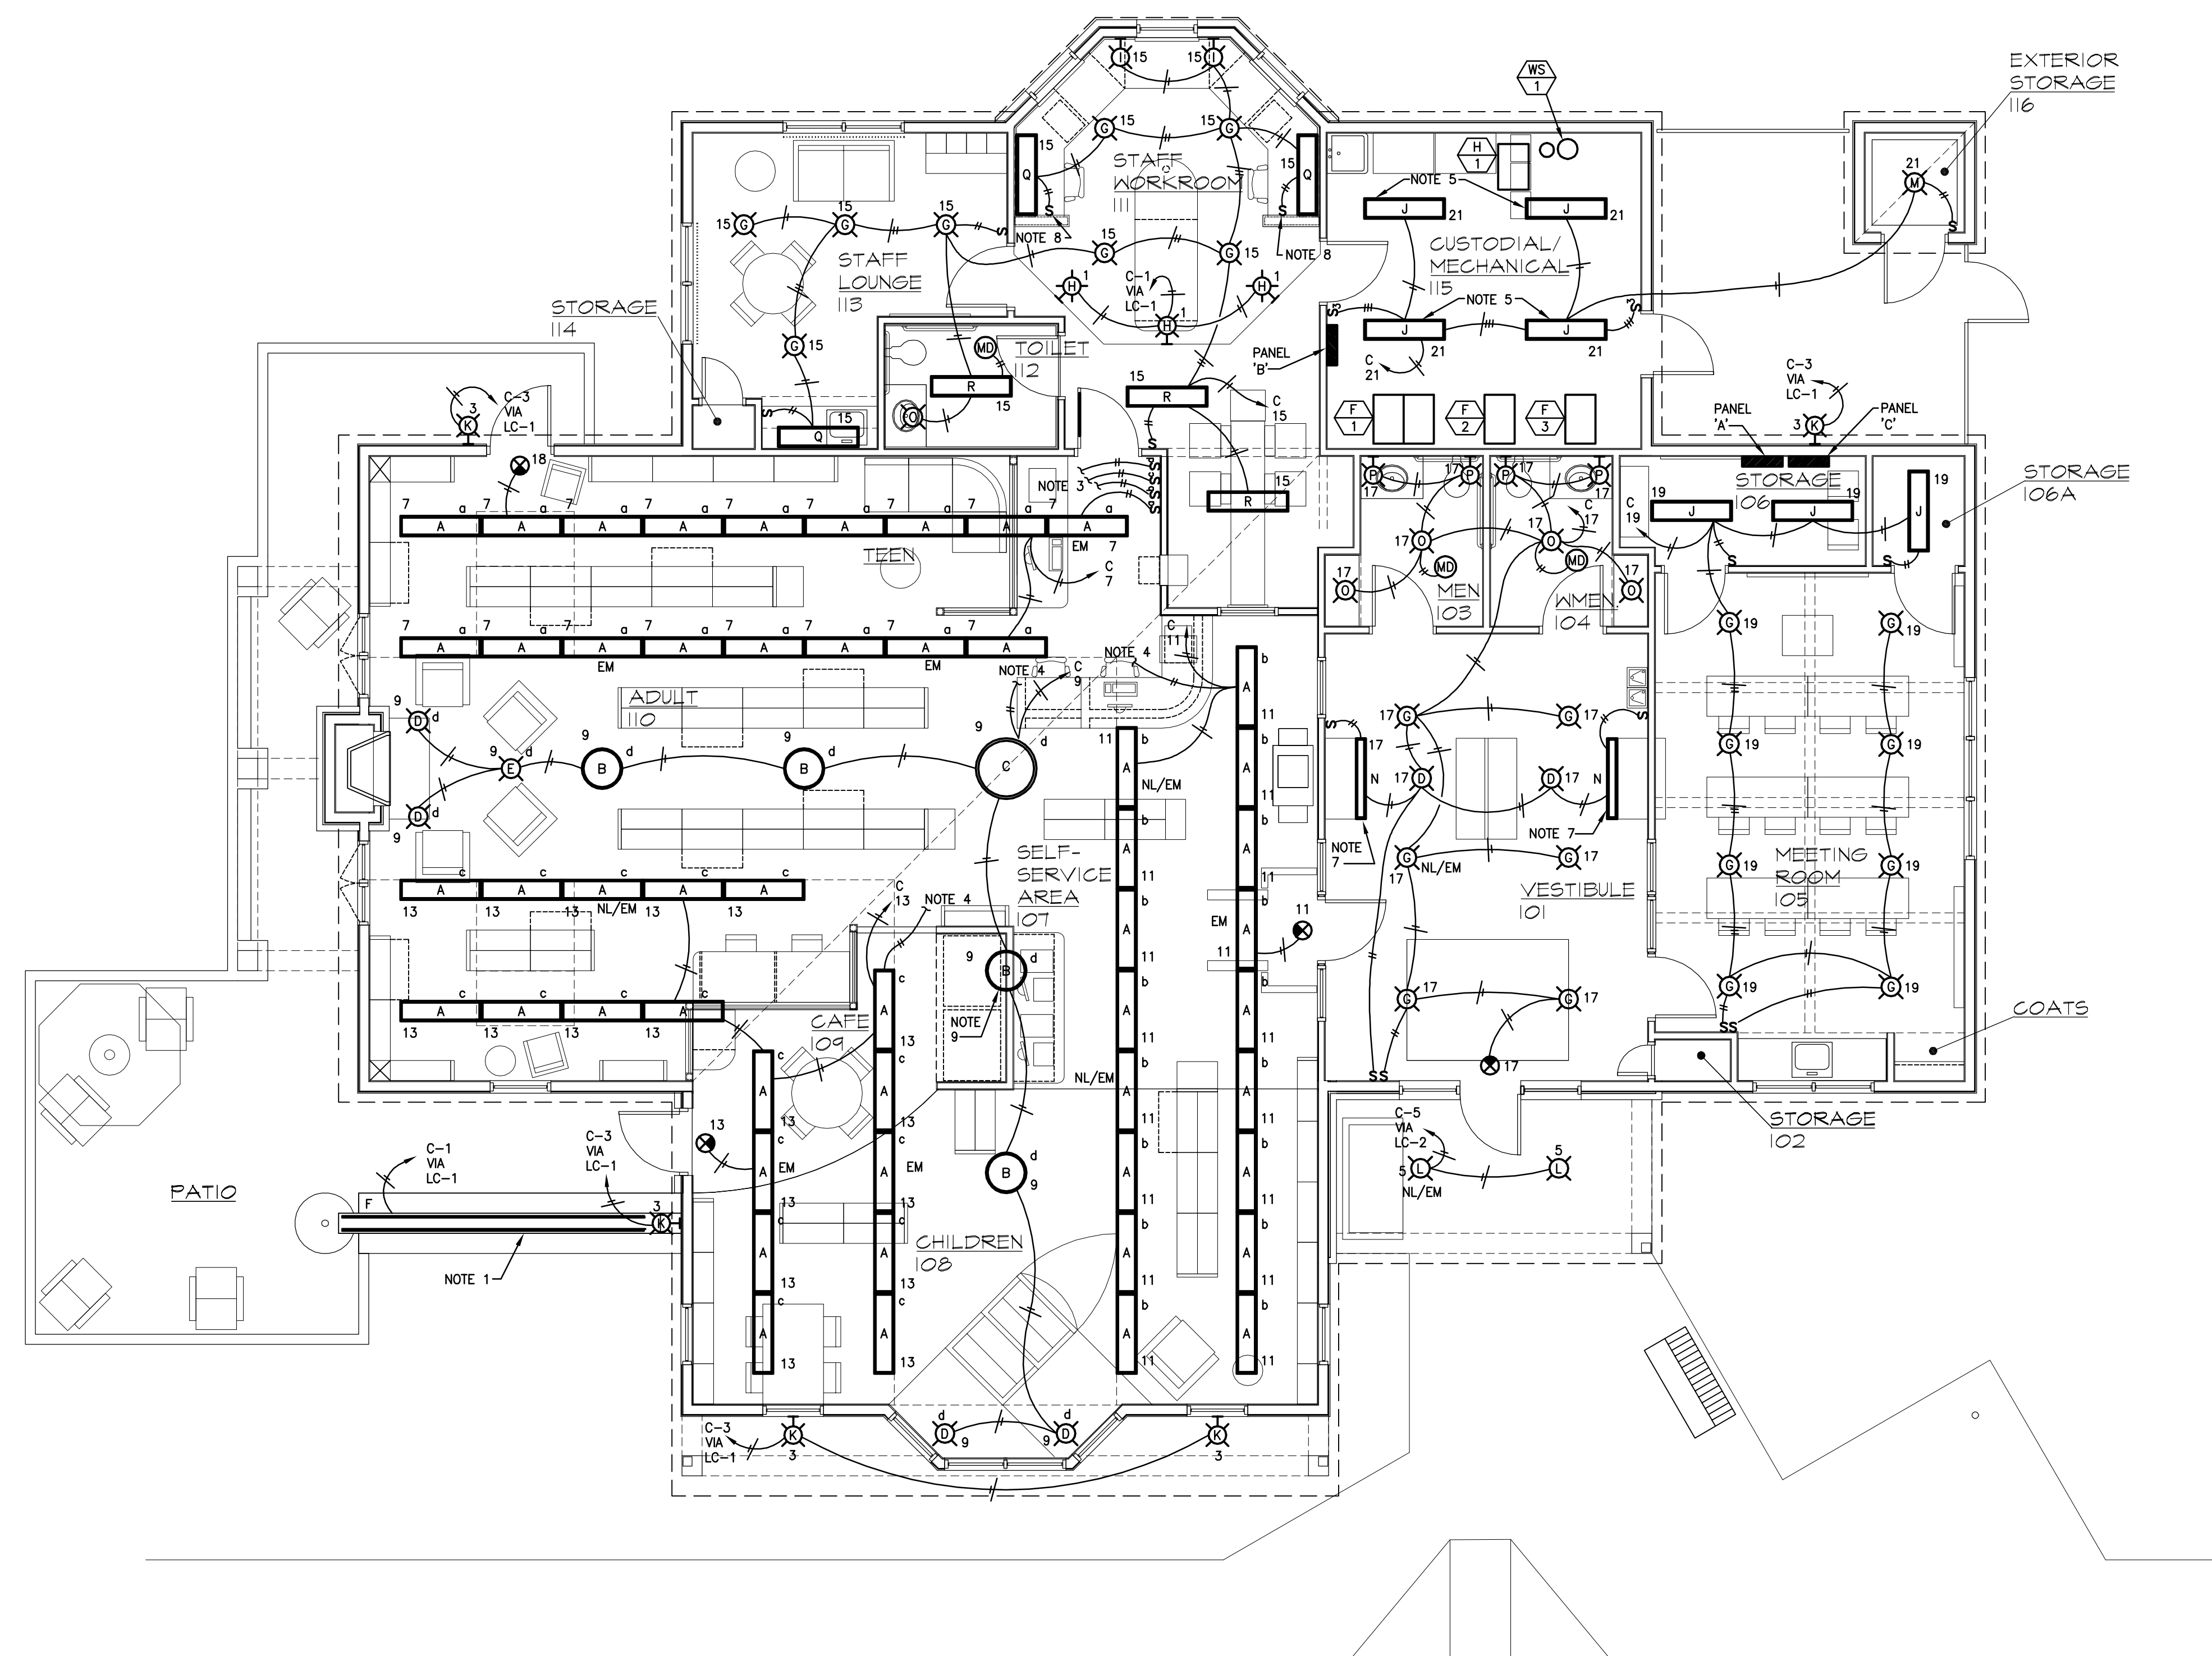

**LIGHTING PLAN**  
 SCALE: 3/16" = 1'-0"

**NEW LAKEVILLE COMMUNITY BRANCH**  
**ST. JOSEPH COUNTY PUBLIC LIBRARY**  
 120 NORTH MICHIGAN STREET  
 LAKEVILLE, INDIANA

DATE: 9/11/06  
 REV: 9/14/06  
 DRAWN BY: JH

SHEET NO.  
**E2.0**