



Thomas R. Cook



NOTE:
 REF SPECIFICATION 15110
 FOR PIPING REQUIREMENTS
 FOR WASTE PIPE BELOW
 SLAB.

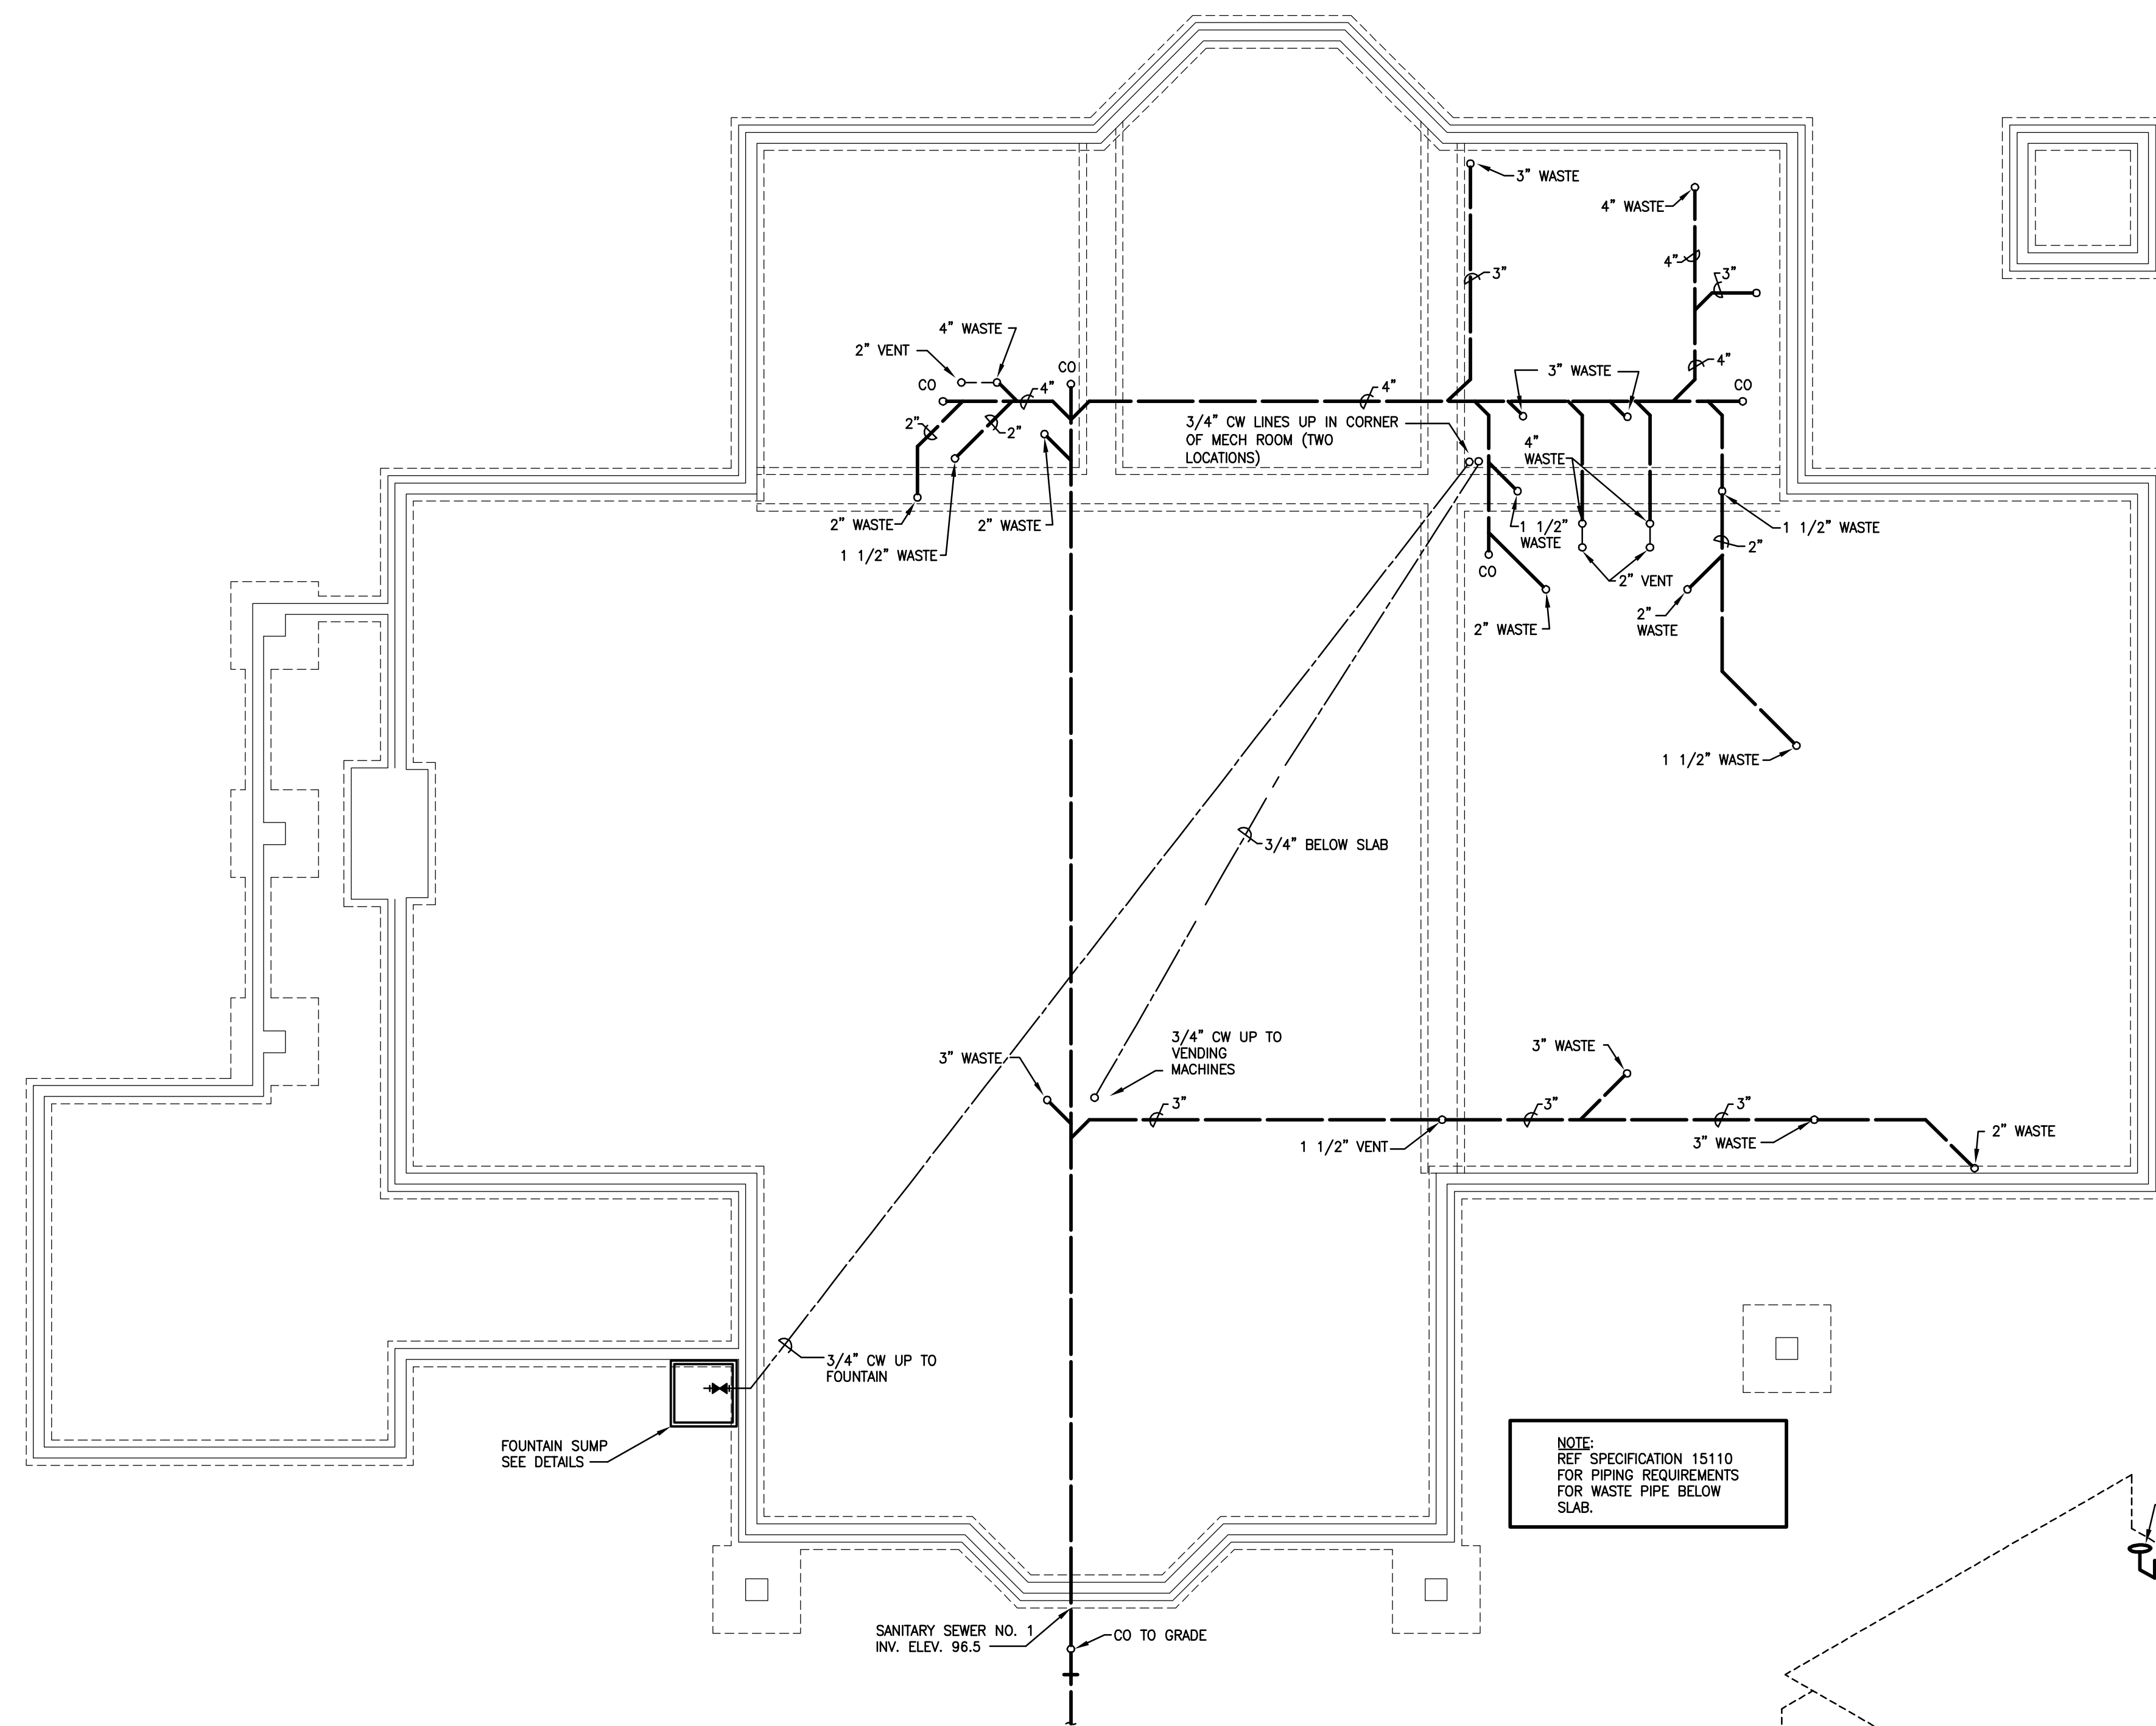

FOUNDATION PLUMBING PLAN
 SCALE: 3/16" = 1'-0"

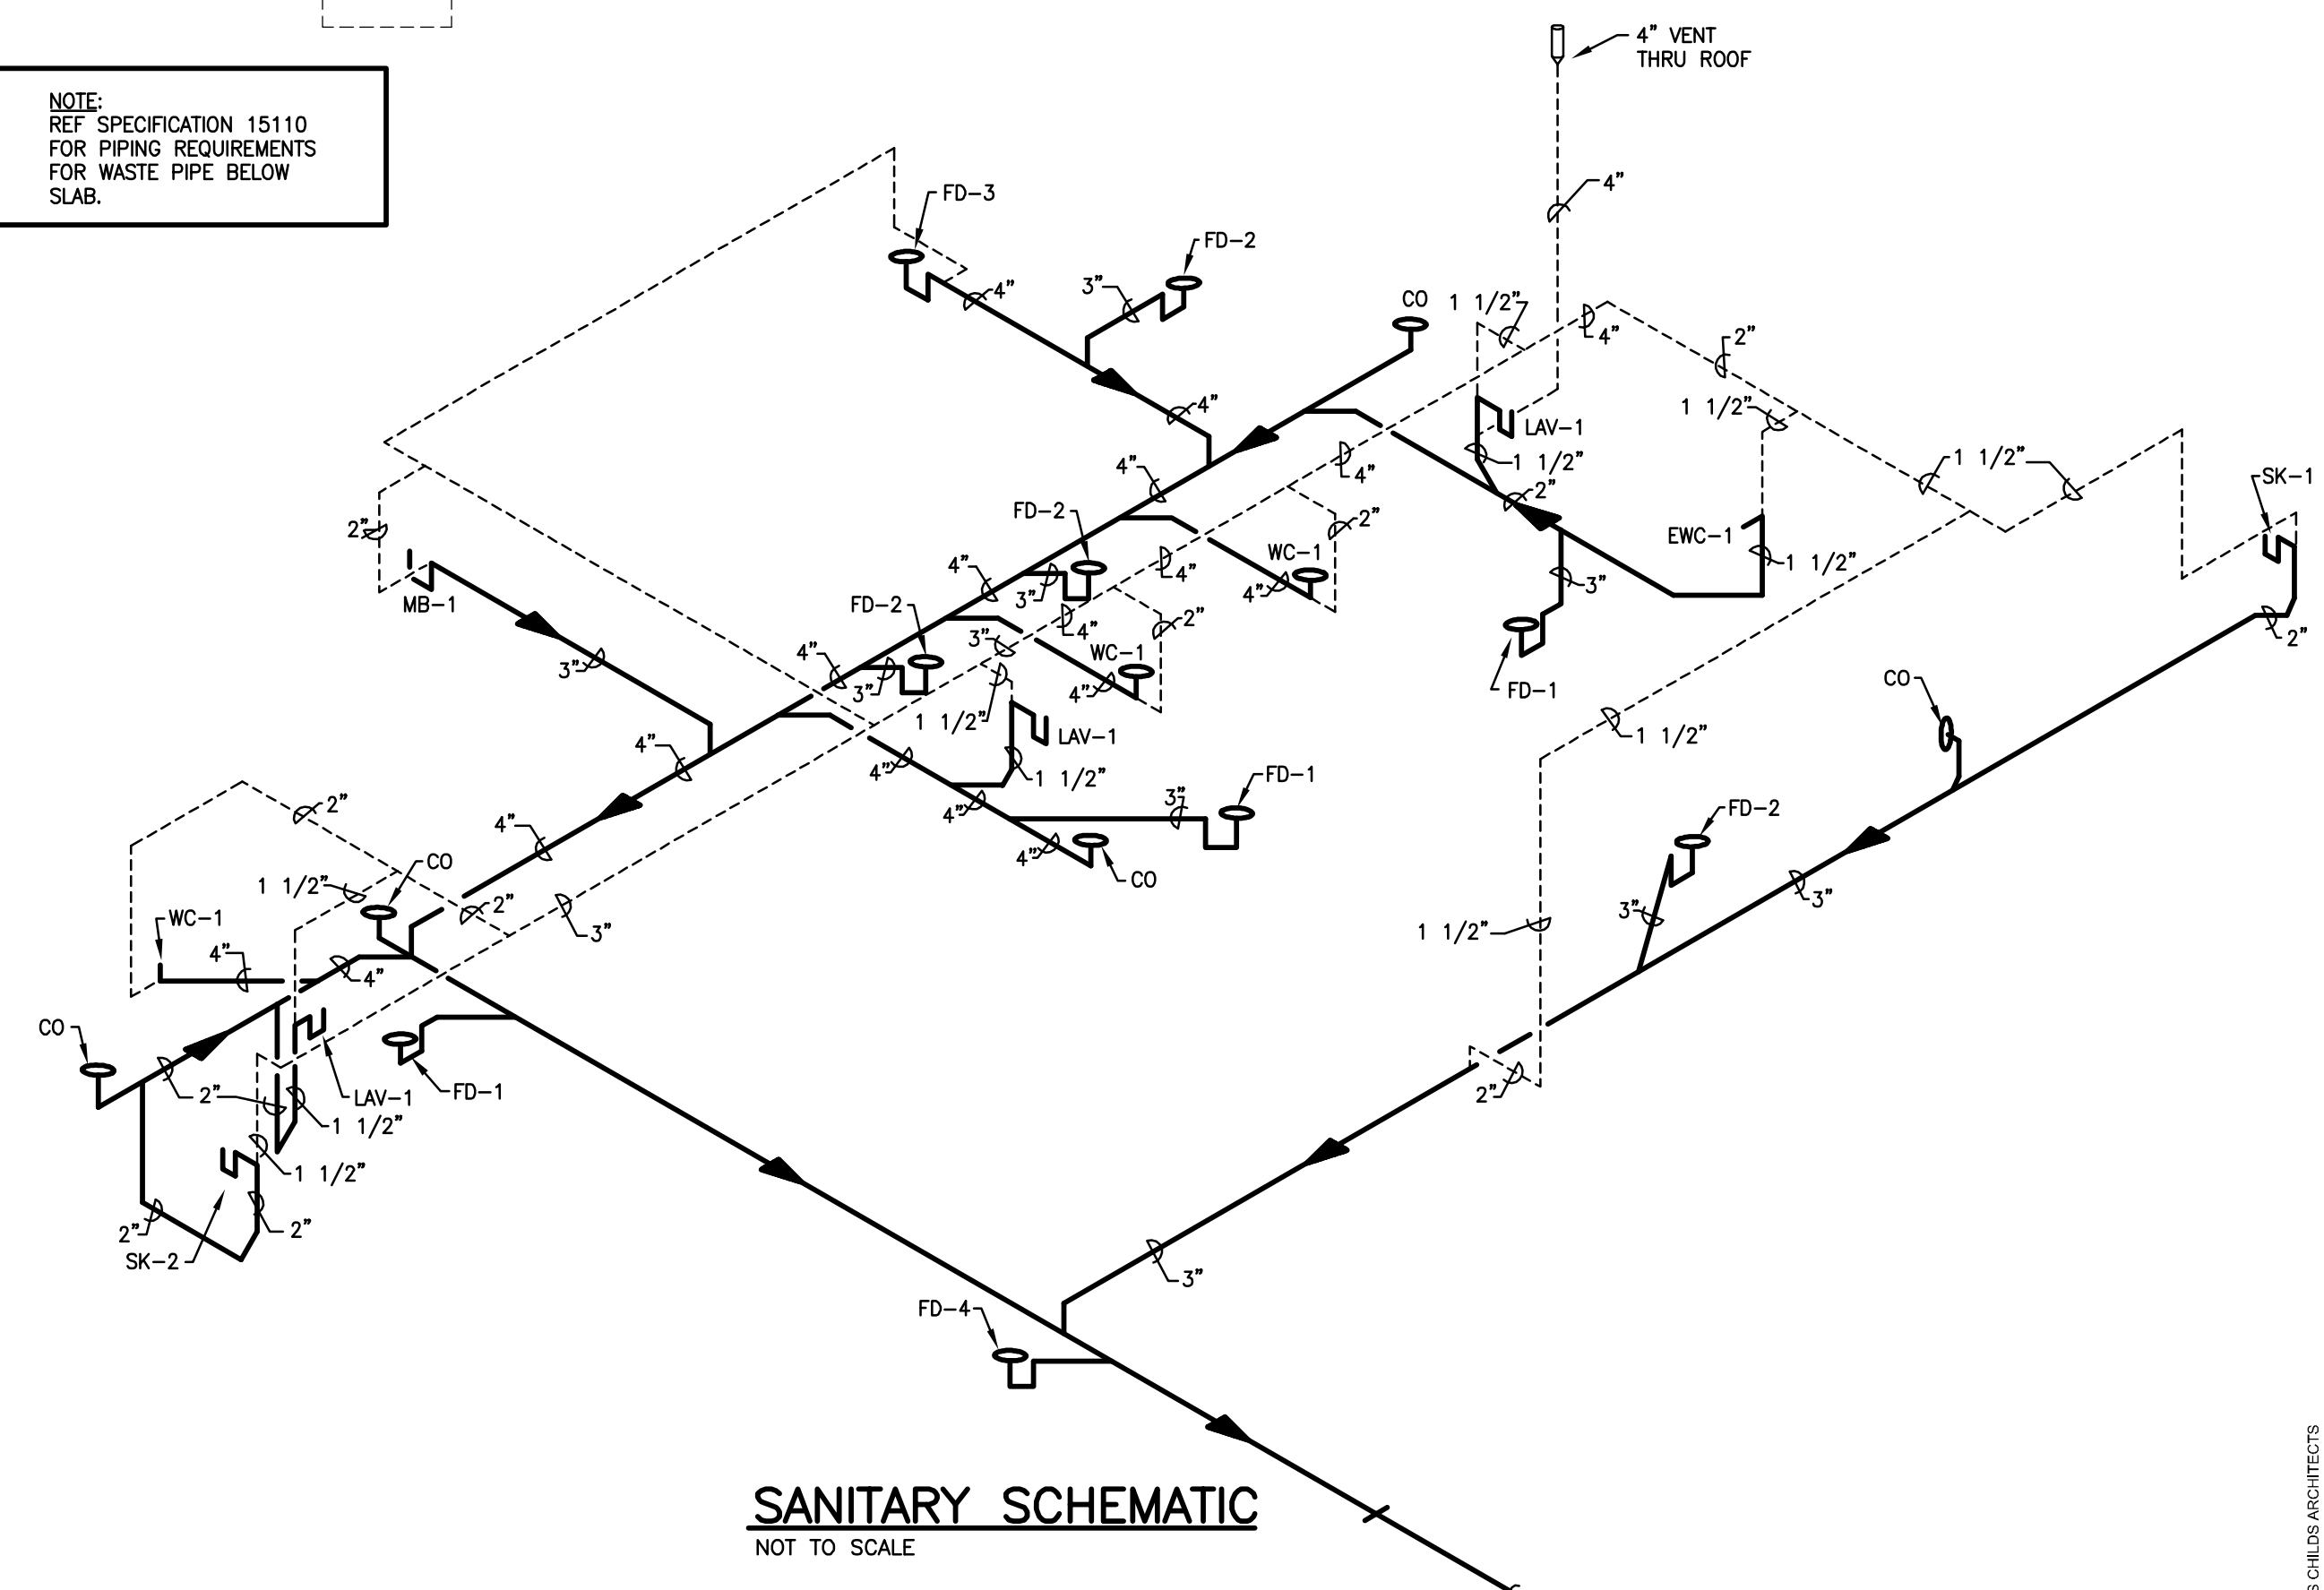

SANITARY SCHEMATIC
 NOT TO SCALE

DATE: 9/11/06
 REV: 9/14/06
 DRAWN BY: J.H.

SHEET NO.
M1.1