

DATE:	MARCH 8, 2006
FILE:	
DRAWN BY:	JLH
CHECKED BY:	TH
REVISIONS:	




FORUM ARCHITECTS, LLC
 Suite 200
 Indiana
 South Bend
 Phone: 219.233.2119
 Fax: 219.288.0924

NEW BUILDING FOR:
ST. JOSEPH COUNTY PUBLIC LIBRARY
 NORTH LIBERTY BRANCH
 NORTH LIBERTY, INDIANA
 MAIN & MARKET STREETS

PLUMBING
 FLOOR PLAN

M102

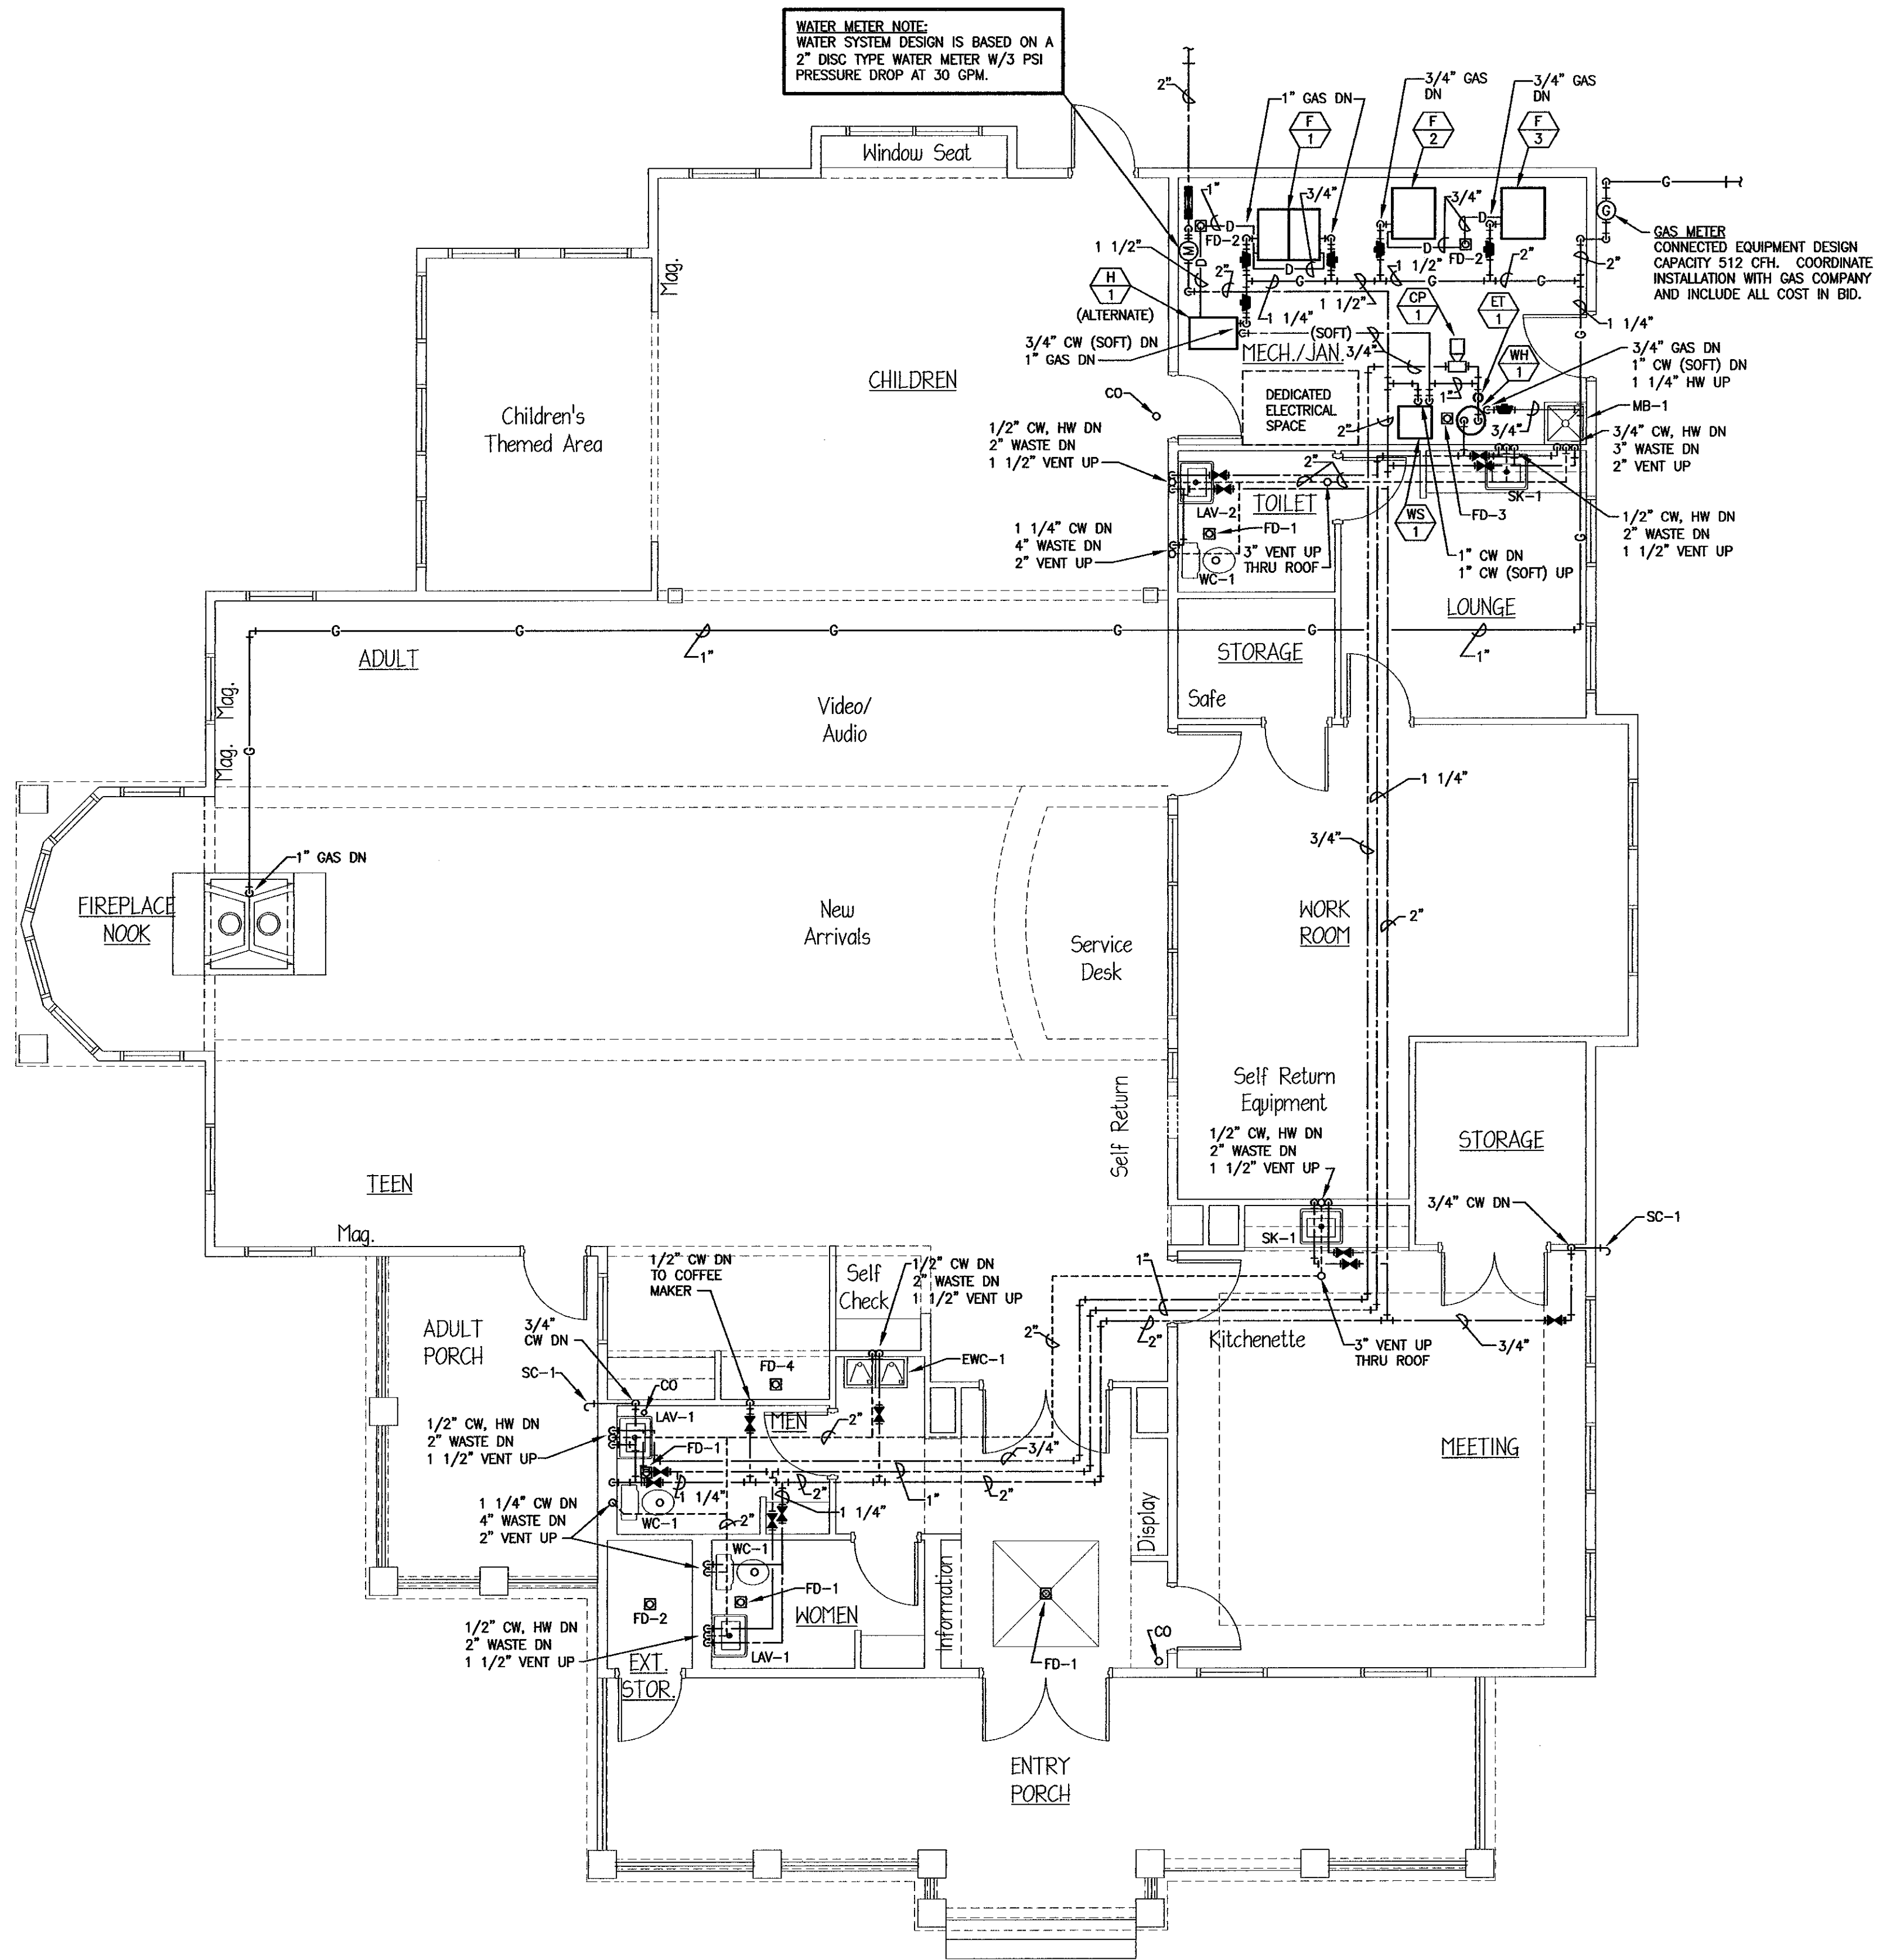

NORTH

PLUMBING FLOOR PLAN
 SCALE: 3/16"=1'-0"